
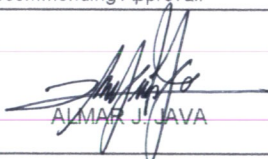






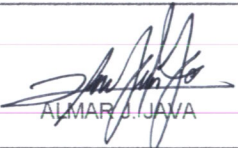
 



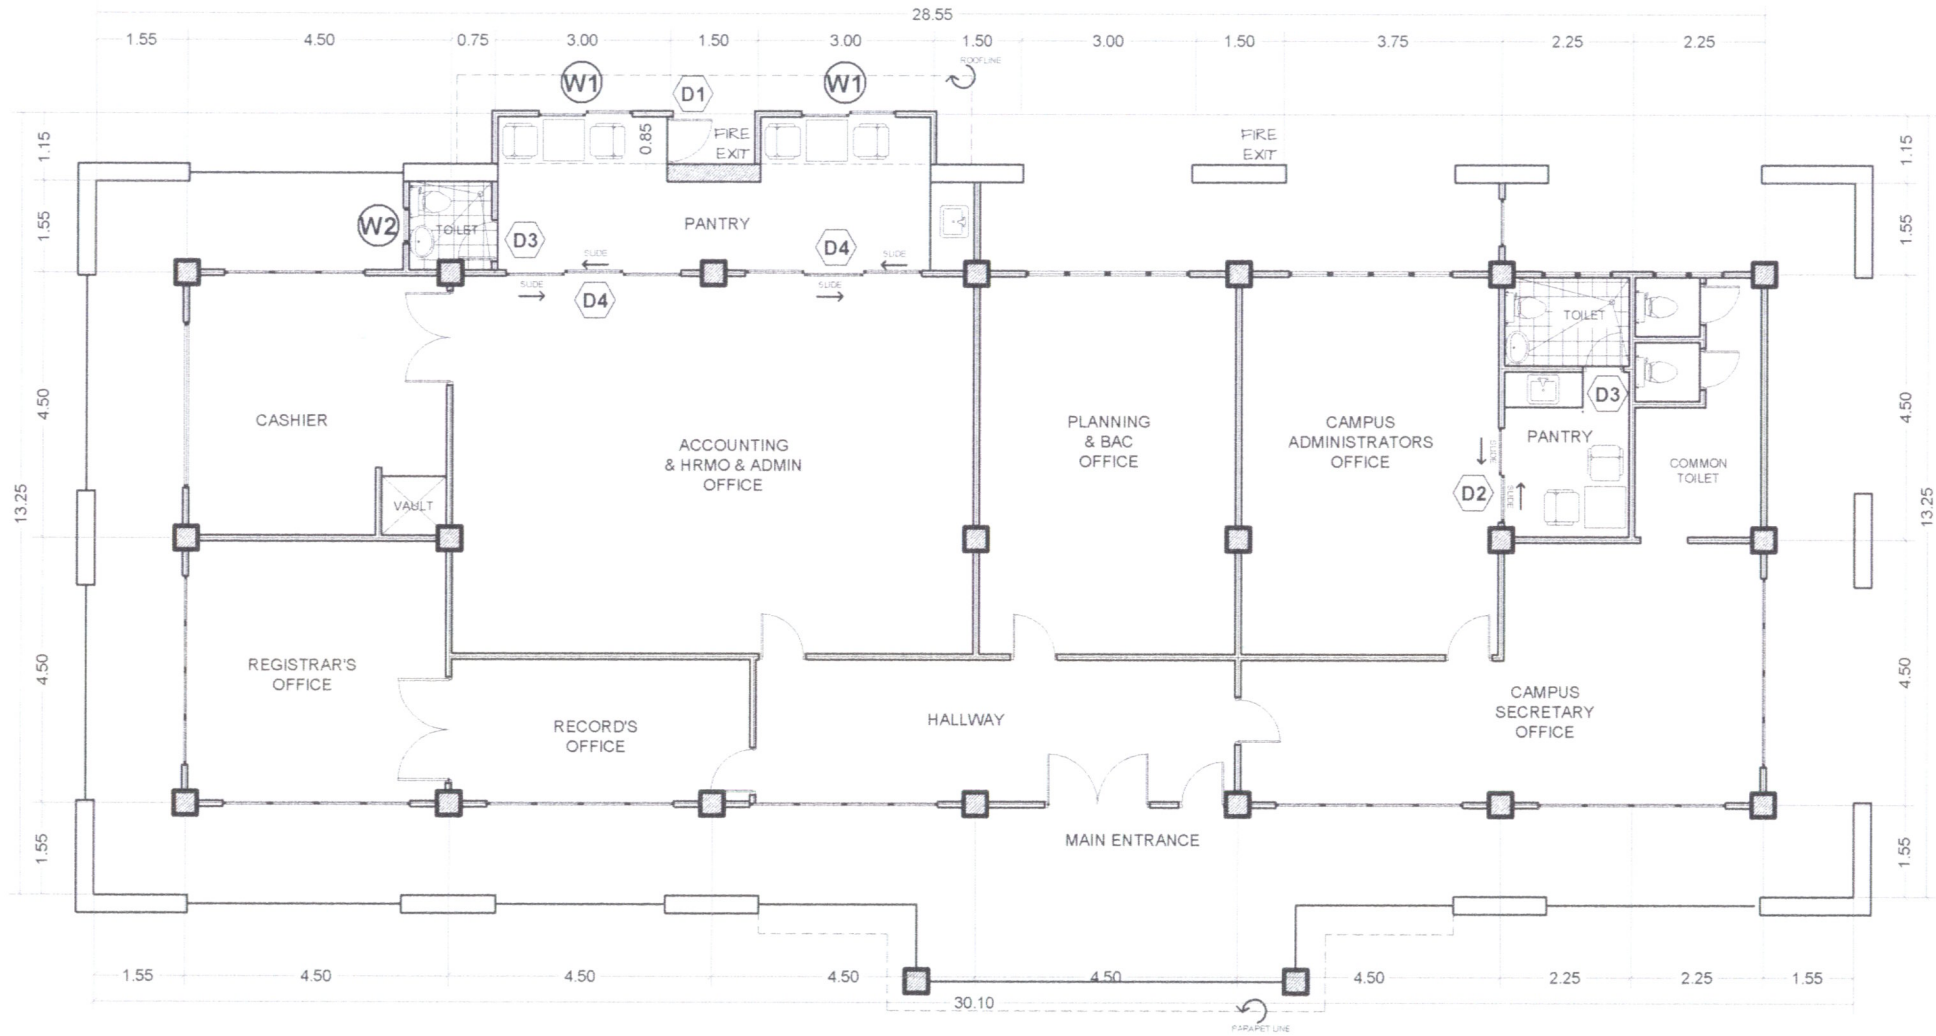
○ PERSPECTIVE

	CITY ENGINEERS OFFICE CITY OF HIMAMAYLAN	Prepared by:	Project Title:	Recommending Approval:	Approved By:	Sheet Contents:	Sheet No.
		EDELIZ G. BANQUILAY <small>Architect III</small>	IMPROVEMENT OF ADMIN BUILDING	 ALMAR J. JAVA	 GENESIS G. CAMARISTA, Ph.D.		
		Checked:					
REIGNHEL JOB BEDAURE <small>Architect I</small>	REGIE I. CALVO <small>Asst. City Engineer</small>						

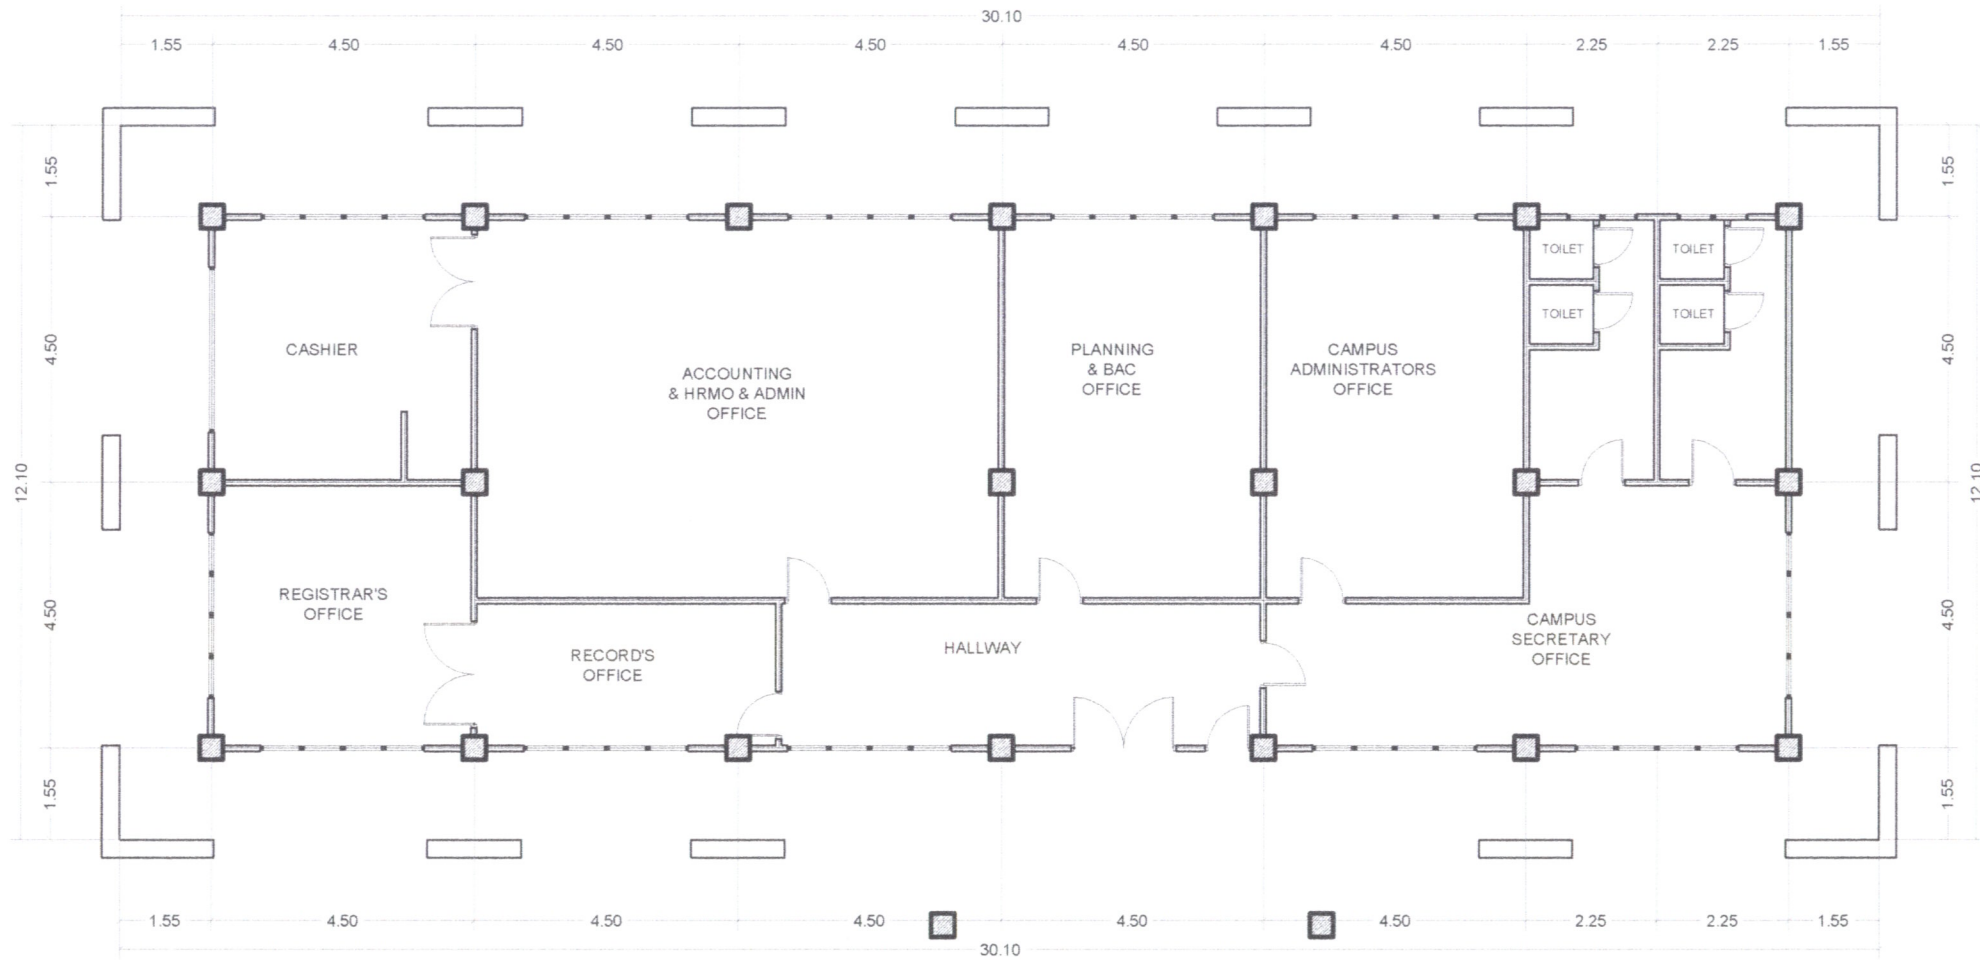

EXISTING FLOOR PLAN
SCALE: 1:110MTS

 <p>CITY ENGINEERS OFFICE CITY OF HIMAMAYLAN</p>	Prepared by:	Project Title:	Recommending Approval:	Approved By:	Sheet Contents:	Sheet No.
	EDELIZ G. BANQUILAY Architect III	IMPROVEMENT OF ADMIN BUILDING	 ALMAR J. JAVA HEAD, PLANNING AND DEVELOPMENT	 GENESIS G. CAMARISTA, Ph.D. CAMPUS ADMINISTRATOR		
	Checked:					
REGIE J. CALVO Asst. City Engineer						





PROPOSED FLOOR PLAN
 SCALE: 1:120MTS




CITY ENGINEERS OFFICE
CITY OF HIMAMAYLAN

 
Prepared by:
 EDELIZ G. BANQUILAY
Architect II
 REIGNHELO B. BEDAURE
Architect I
 Checked:
 REGIE I. CALVO
Asst. City Engineer


Project Title:
**IMPROVEMENT OF
 ADMIN BUILDING**
 Location: Brgy. Caradio-an, Himamaylan City

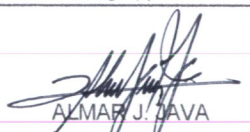Recommending Approval:

 ALMAR J. DAVA
 HEAD, PLANNING AND DEVELOPMENT


Approved By:

 GENESIS G. CAMARISTA, Ph.D.
 CAMPUS ADMINISTRATOR

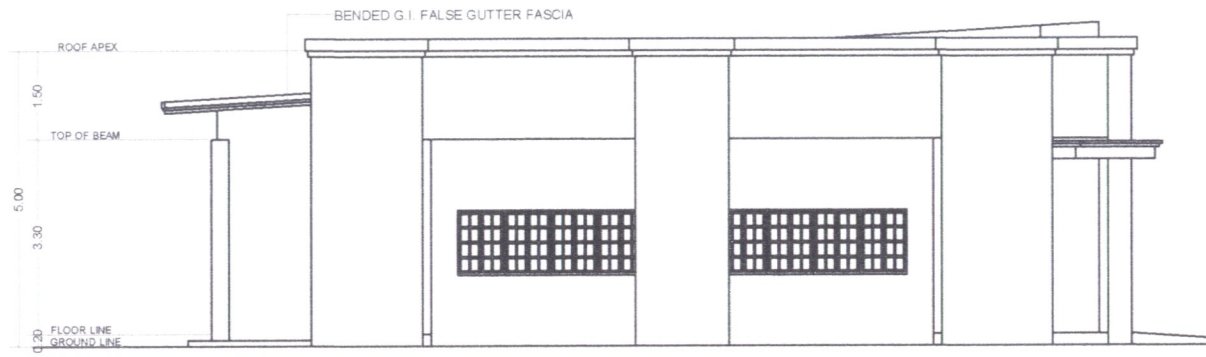Sheet Contents:

Sheet No.

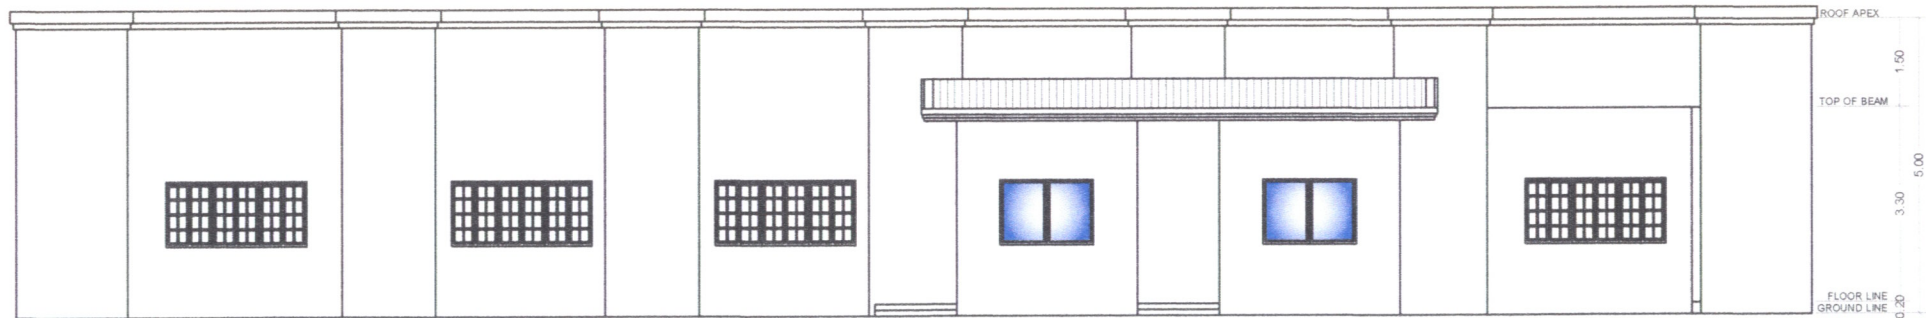


LEFT-SIDE ELEVATION
SCALE: 1:120MTS



REAR ELEVATION
SCALE: 1:120MTS



**CITY ENGINEERS OFFICE
CITY OF HIMAMAYLAN**

Prepared by:
EDELIZ G. BANQUILAY
Architect III
REIGNHEL JOB BEDAURE
Architect I
Checked:
REGIE M. CALVO
Asst. City Engineer

Project Title:
**IMPROVEMENT OF
ADMIN BUILDING**
Location: Brgy. Caradio-an, Himamaylan City

Recommending Approval:


ALMAR J. JAVA
HEAD, PLANNING AND DEVELOPMENT

Approved By:

GENESIS G. CAMARISTA, Ph.D.
CAMPUS ADMINISTRATOR

Sheet Contents:

Sheet No.

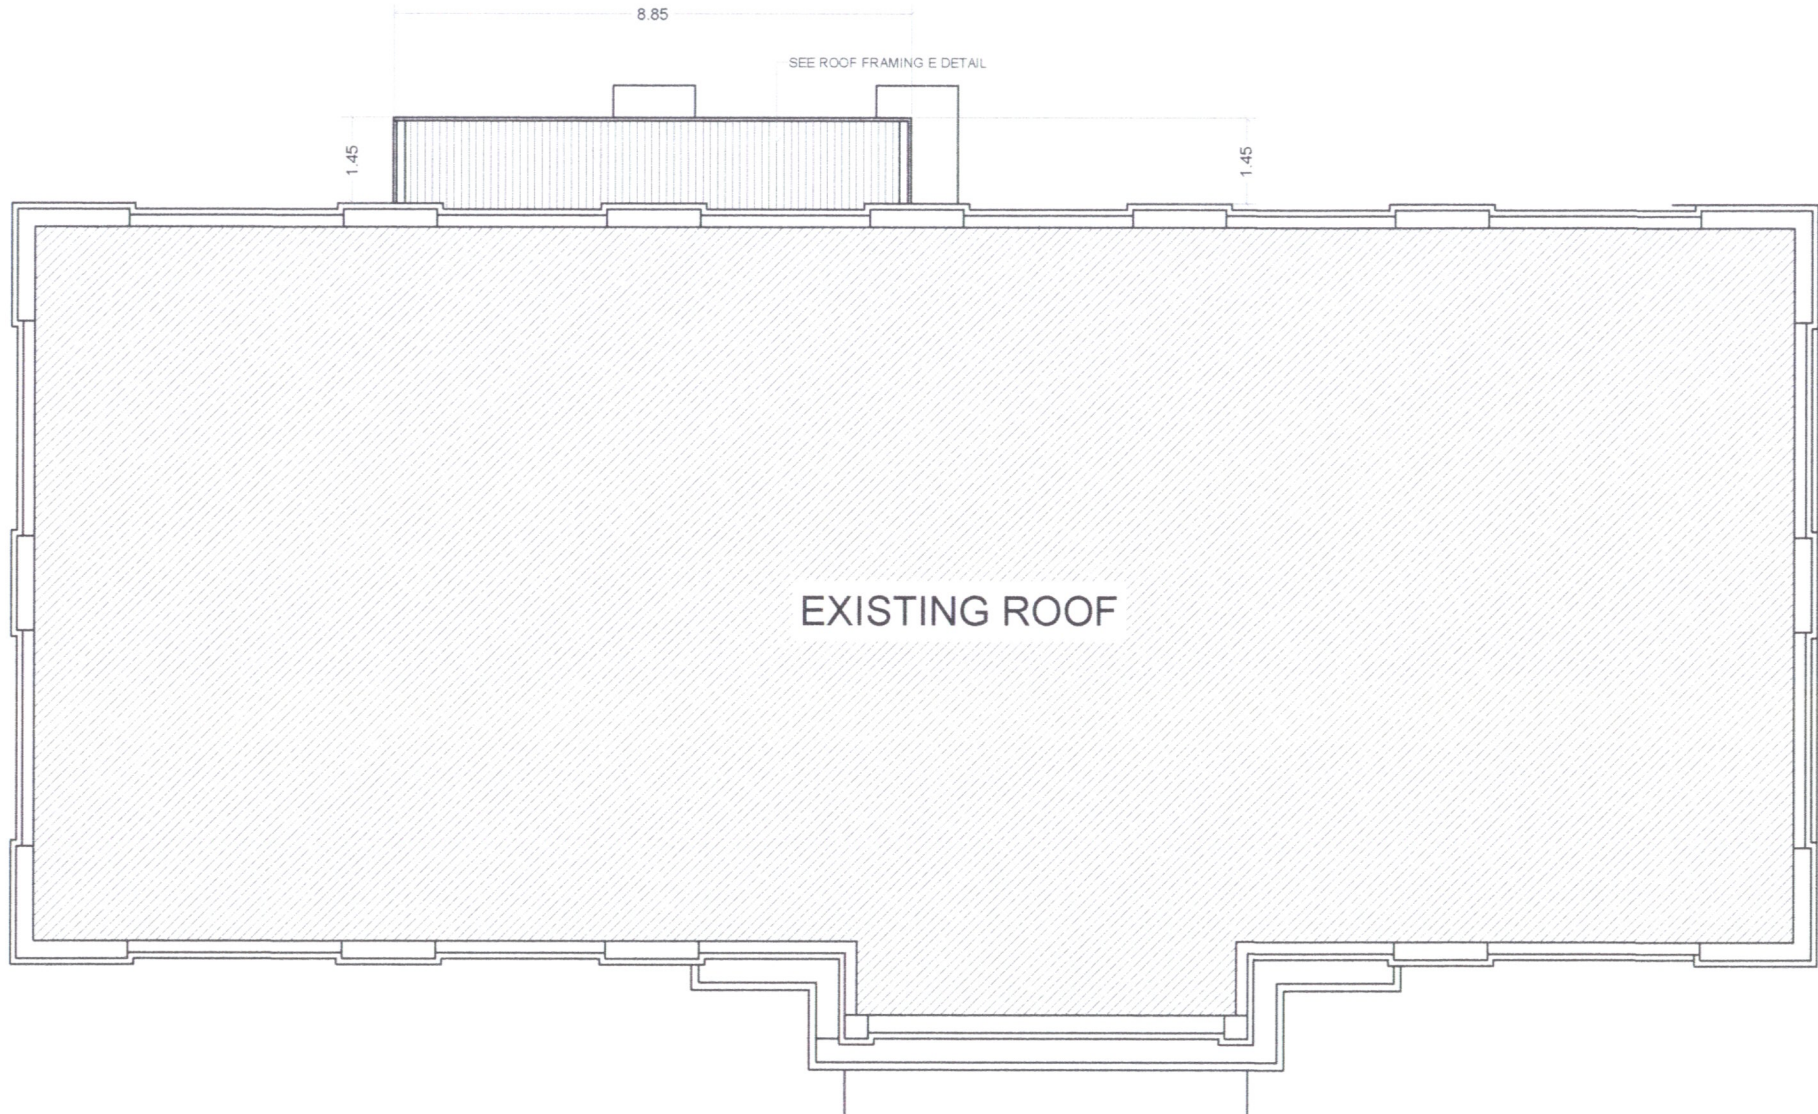

ROOF PLAN
SCALE: 1:120MTS



**CITY ENGINEERS OFFICE
CITY OF HIMAMAYLAN**

Prepared by:
EDELIZ G. BANGUILAY
Architect III
REIGNHEL JOB BEDAURE
Architect I
Checked:
REGIE L. CALVO
Asst. City Engineer

Project Title:
**IMPROVEMENT OF
ADMIN BUILDING**
Location: Brgy. Caradio-an, Himamaylan City

Recommending Approval:

ALMAR A. JAVA
HEAD, PLANNING AND DEVELOPMENT

Approved By:





GENESIS G. CAMARISTA, Ph.D.
CAMPUS ADMINISTRATOR

Sheet Contents:



Sheet No.


**A-6
6**

SCHEDULE OF DOORS

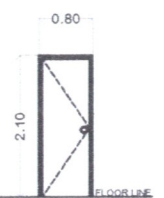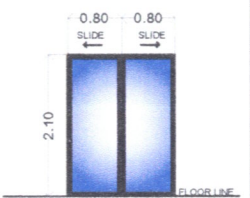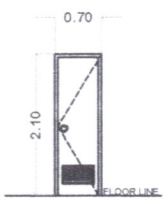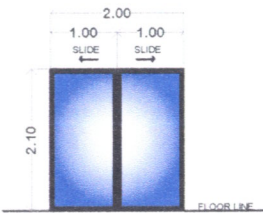 <p style="text-align: center;">D1</p>	 <p style="text-align: center;">D2</p>	 <p style="text-align: center;">D3</p>	 <p style="text-align: center;">D4</p>
MATERIAL: HOLLOW-CORE WOOD DOOR w/ COMPLETE ACCESSORIES	MATERIAL: 6MM THK. GLASS DOOR w/ ANALOK FRAME	MATERIAL: uPVC DOOR w/ LOUVRE & COMPLETE ACCESSORIES	MATERIAL: 6MM THK. GLASS DOOR w/ ANALOK FRAME
TYPE: PANEL-TYPE DOOR	TYPE: SLIDING-TYPE DOOR	TYPE: PANEL-TYPE DOOR	TYPE: SLIDING-TYPE DOOR
LOCATION: MAIN ENTRANCE, STORAGE, SERVER ROOM & PANTRY	LOCATION: CAMPUS ADMINISTRATOR'S PANTRY	LOCATION: TOILETS	LOCATION: PANTRY
DIMENSION: (0.80M x 2.10M)	DIMENSION: (0.80M x 2.10M)	DIMENSION: (0.70M x 2.10M)	DIMENSION: (1.00M x 2.10M)
UNITS: SIX (6)	UNITS: ONE (1)	UNITS: ONE (1)	UNITS: TWO (2)
SETS: ONE (1)	SETS: FIVE (5)	SETS: TWO (2)	SETS: FOUR (4)

SCHEDULE OF WINDOWS

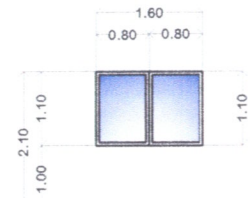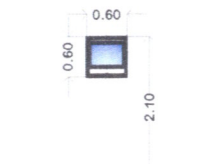 <p style="text-align: center;">W1</p>	 <p style="text-align: center;">W2</p>
MATERIAL: 6MM THK. GLASS WINDOW w/ ANALOK FRAME	MATERIAL: 6MM THK. GLASS WINDOW w/ ANALOK FRAME
TYPE: SLIDING-TYPE DOOR	TYPE: AWNING-TYPE DOOR
LOCATION: OFFICES	LOCATION: TOILETS
DIMENSION: (0.80M x 1.10M)	DIMENSION: (0.60M x 0.60M)
UNITS: TWO (2)	UNITS: ONE (1)
SETS: FOUR (4)	SETS: TWO (2)

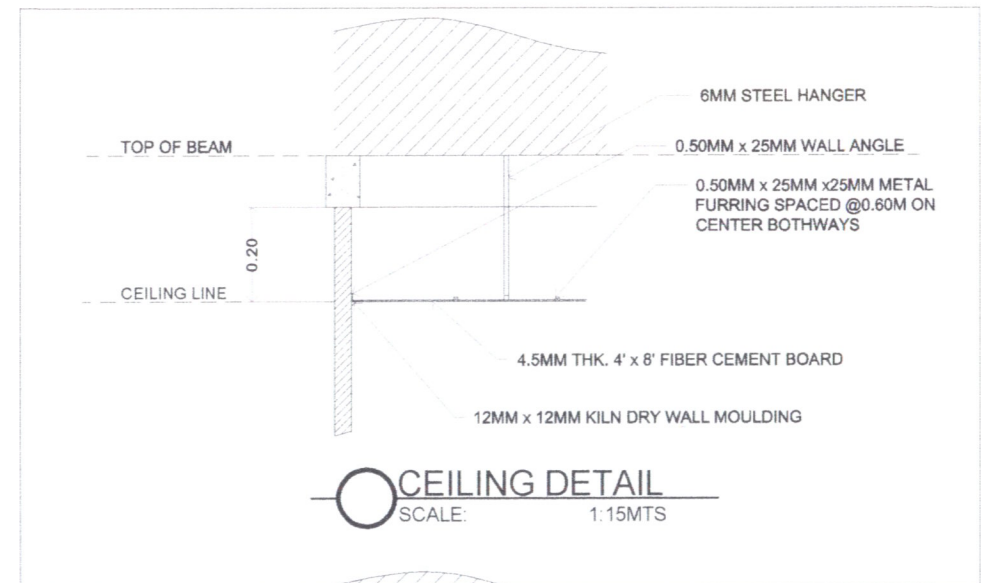

**CITY ENGINEERS OFFICE
CITY OF HIMAMAYLAN**

Prepared by:

EDELIZ G. BANQUILAY
Architect III

Checked by:
REIGNHEL JOSE BEDAURE
Architect I


REGIE J. CALVO
Asst. City Engineer

Project Title:

**IMPROVEMENT OF
ADMIN BUILDING**


Location: Brgy. Caradio-an, Himamaylan City

Recommending Approval:

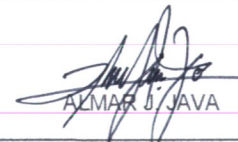
ALMAR J. JAVA

HEAD, PLANNING AND DEVELOPMENT

Approved By:

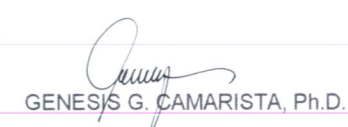

GENESIS G. CAMARISTA, Ph.D.

CAMPUS ADMINISTRATOR


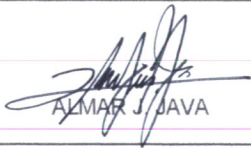
 

Sheet Contents:


Sheet No.

**A-7
7**

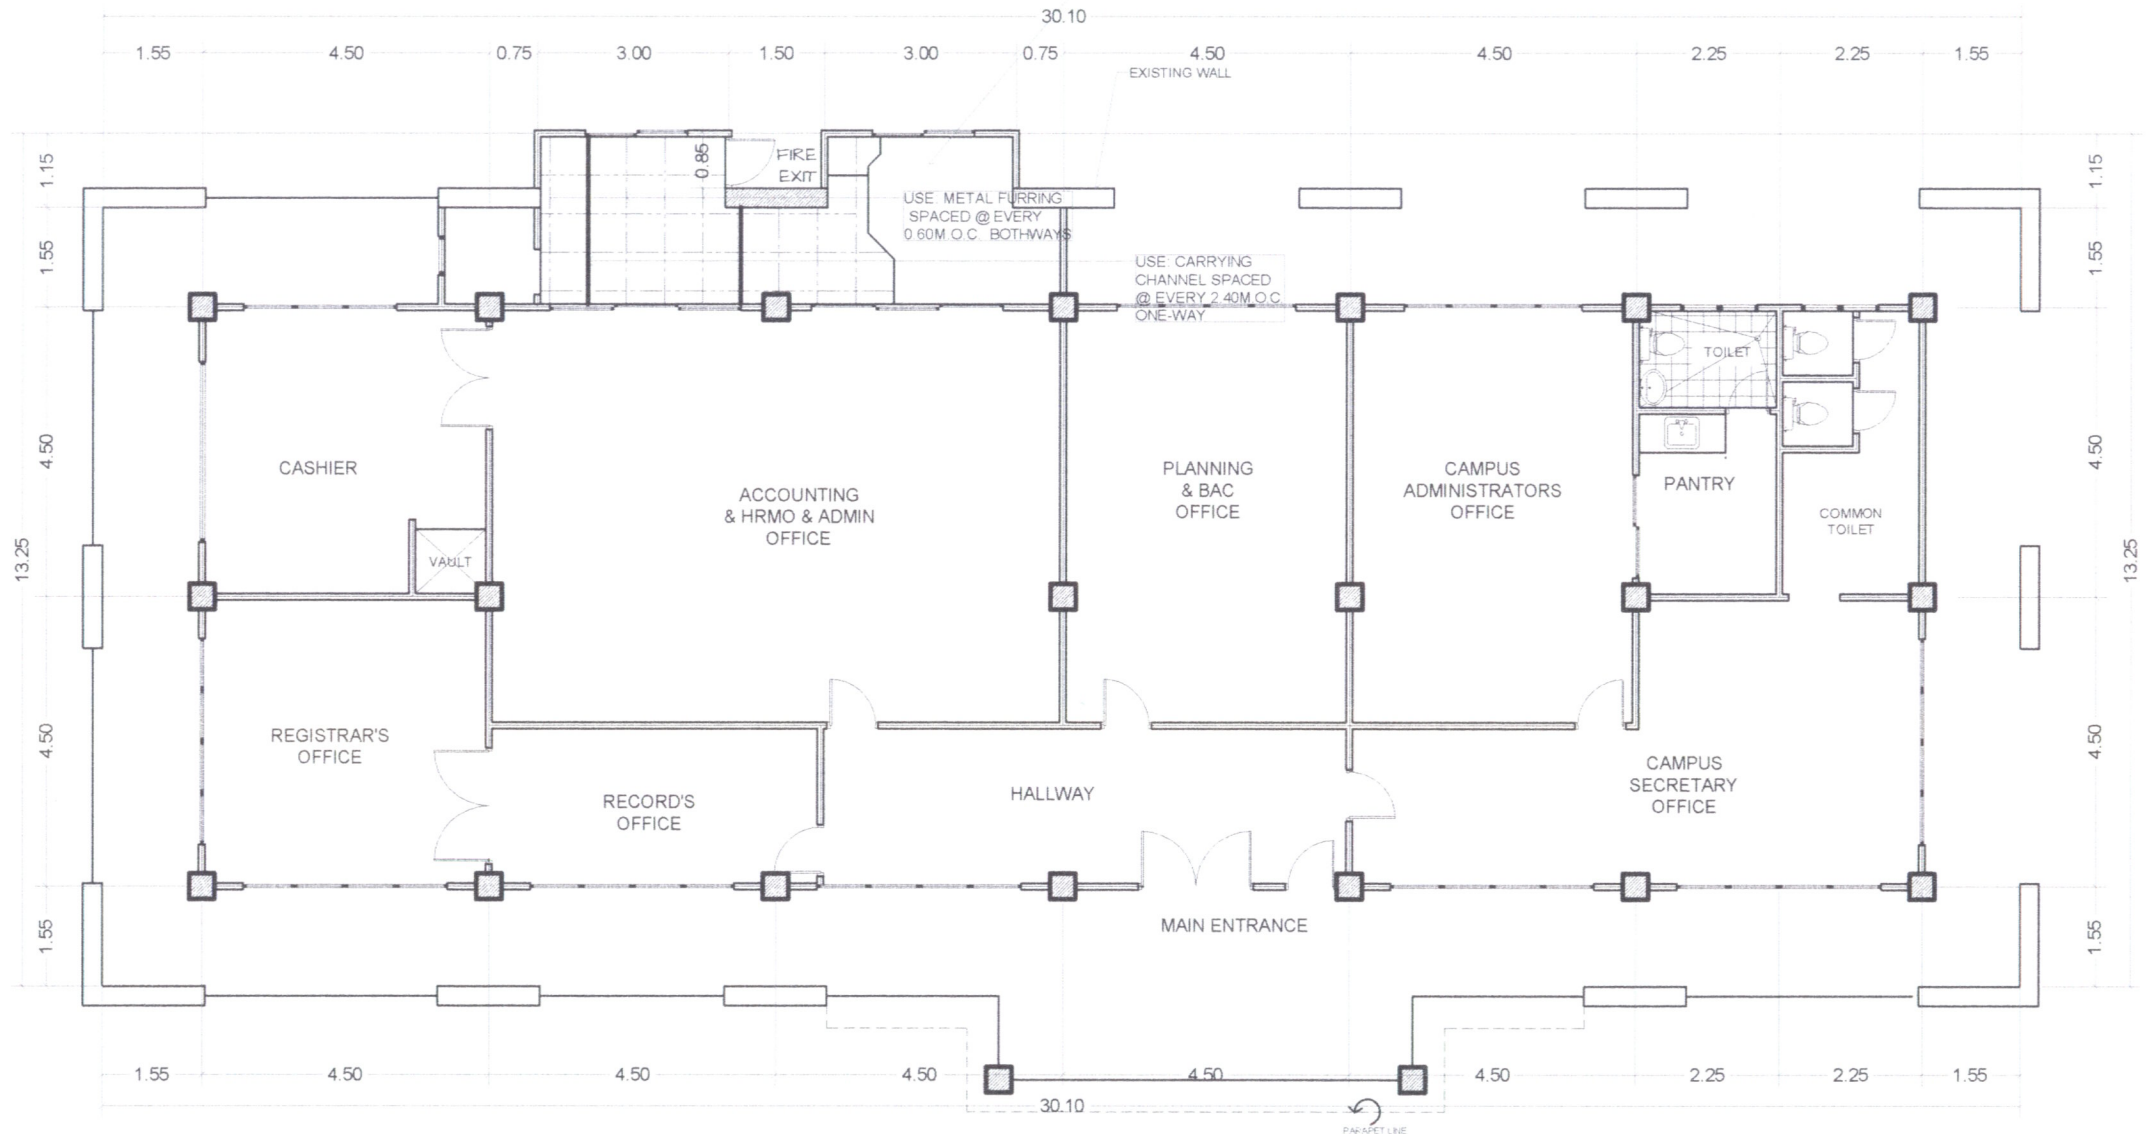


REFLECTED CEILING PLAN
SCALE: 1:110MTS

 <p>CITY ENGINEERS OFFICE CITY OF HIMAMAYLAN</p>	Prepared by:	Project Title:	Recommending Approval:	Approved By:	Sheet Contents:	Sheet No.
	EDELIZ G. BANQUILAY Architect III	IMPROVEMENT OF ADMIN BUILDING	 ALMAR J. JAVA HEAD, PLANNING AND DEVELOPMENT	 GENESIS G. CAMARISTA, Ph.D. CAMPUS ADMINISTRATOR		
	Checked:				Location: Brgy. Caradio-an, Himamaylan City	
REGIE J. CALVO Asst. City Engineer						

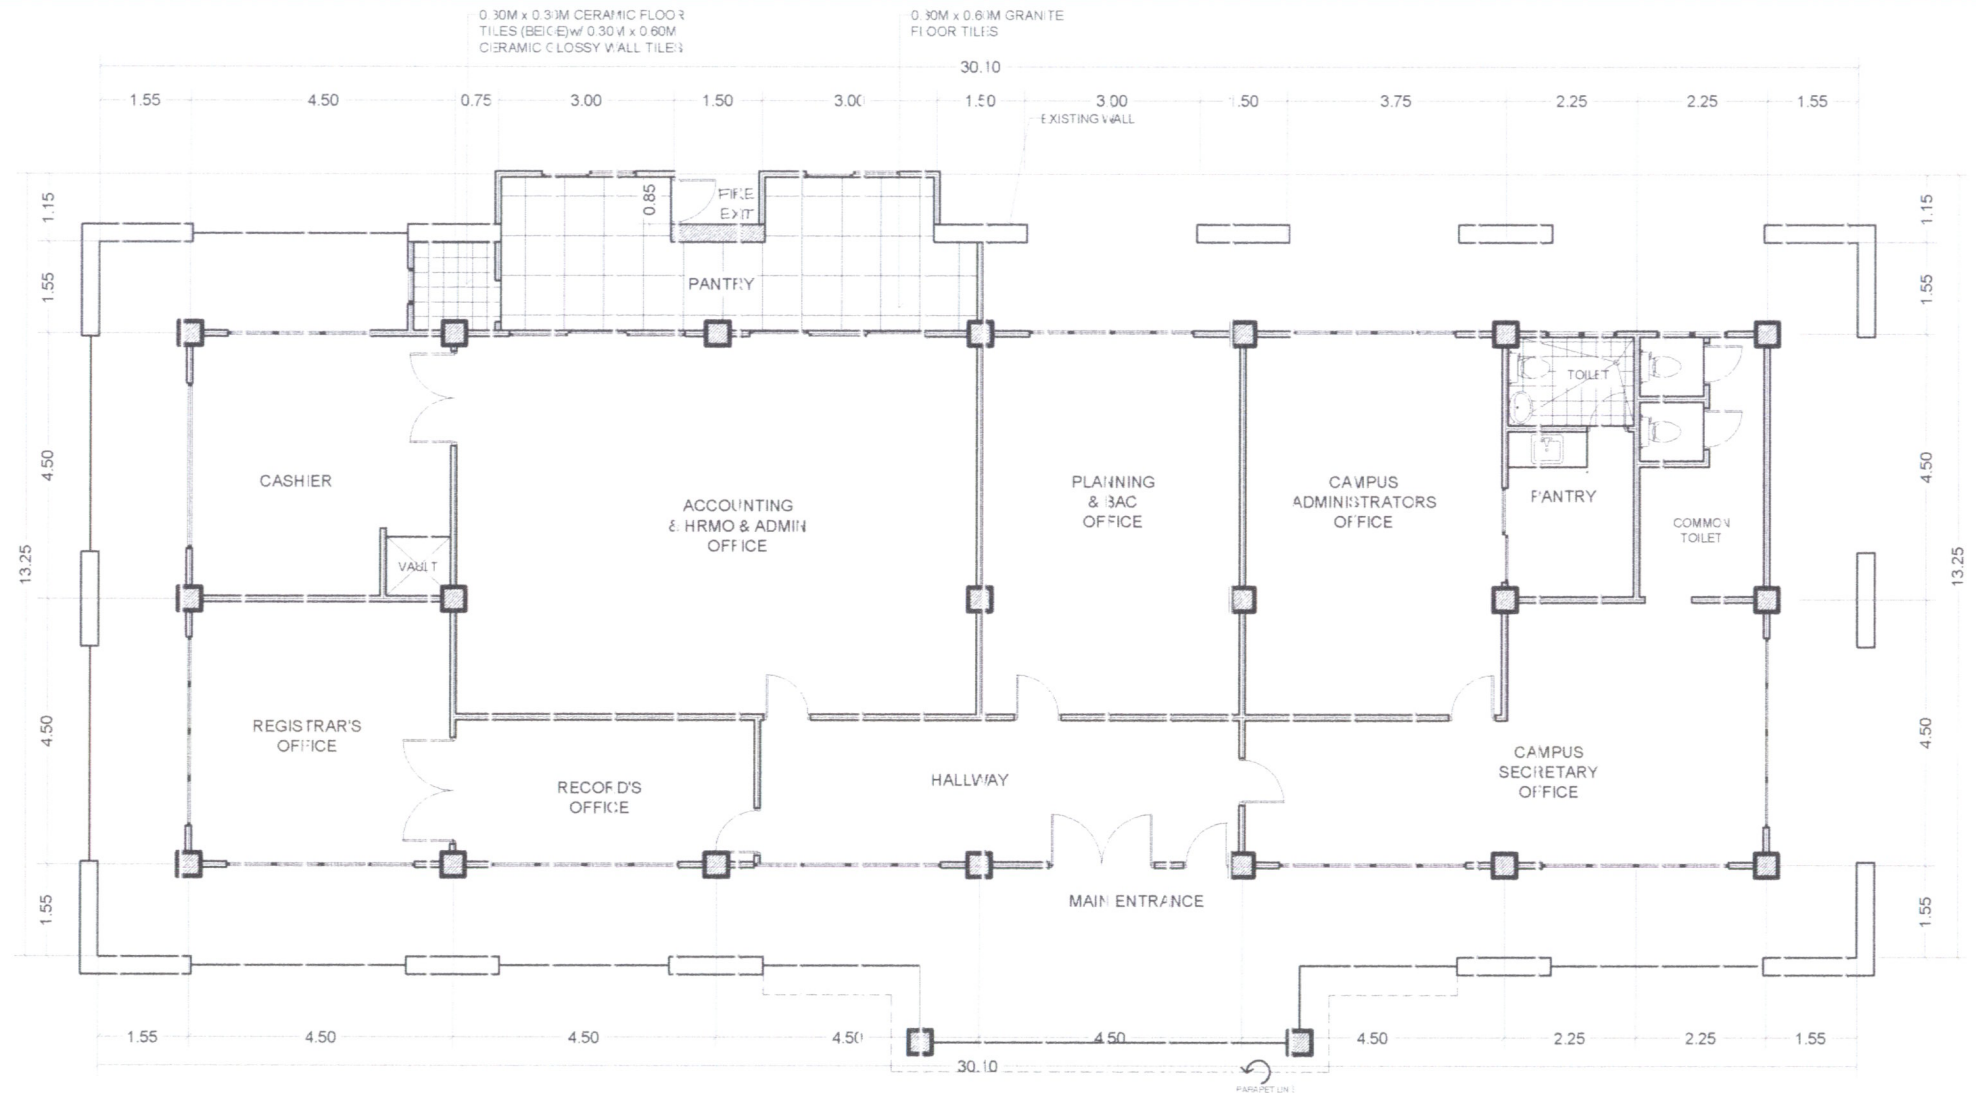

FLOOR & WALL TILE LAYOUT
SCALE: 1:120MTS

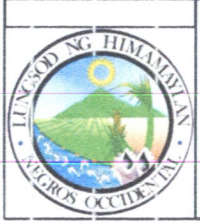

CITY ENGINEERS OFFICE
CITY OF HIMAMAYLAN

Prepared by:
EDELIZ G. BANGUILAY
Architect III

Checked:
REGIE V. CALVO
Asst. City Engineer

Project Title:
**IMPROVEMENT OF
ADMIN BUILDING**


Location: Bigy, Caradio-an, Himamaylan City

Recommending Approval:
Almar S. Java
ALMAR S. JAVA
HEAD, PLANNING AND DEVELOPMENT


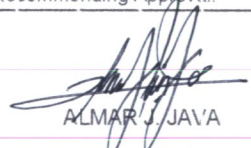


Approved By:
Genesis G. Camarista
GENESIS G. CAMARISTA, Ph.D.
CAMPUS ADMINISTRATOR


Sheet Contents:

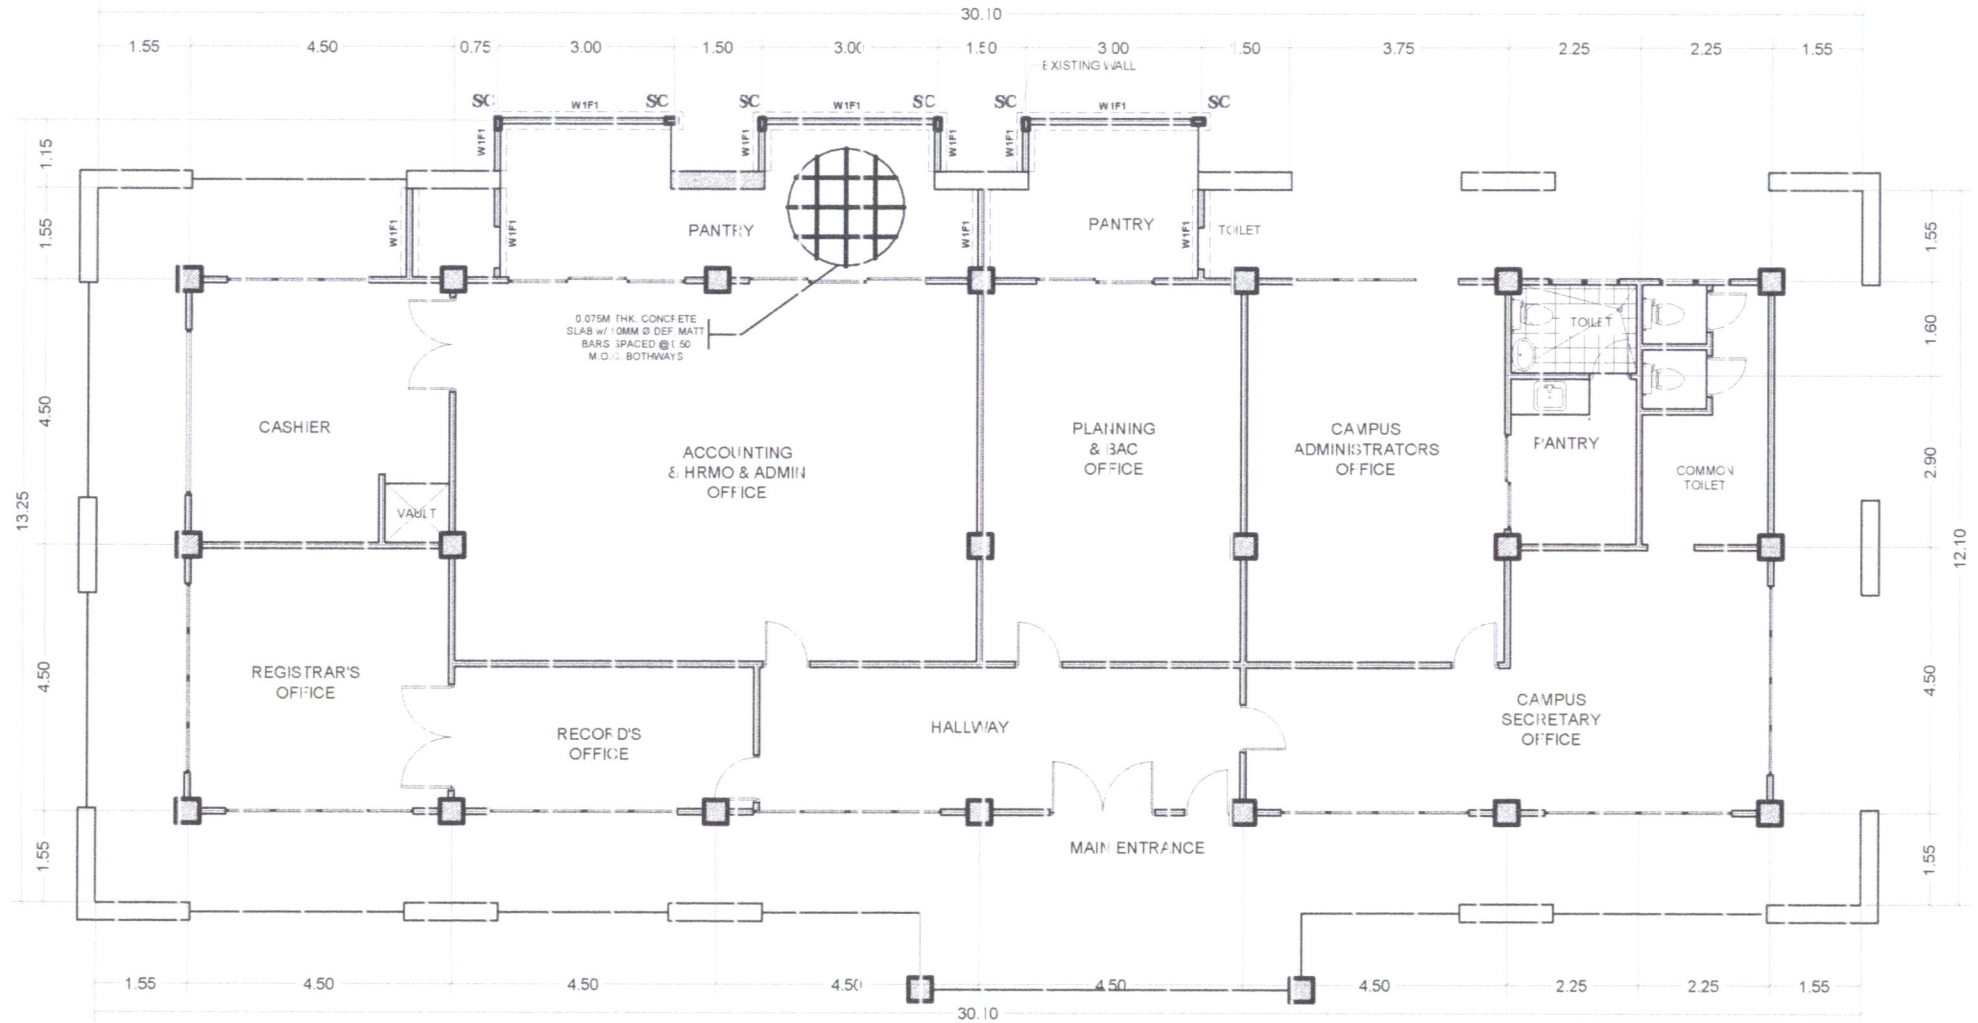Sheet No.
A-9
9



FOUNDATION PLAN
SCALE: 1:120MTS

 <p>CITY ENGINEERS OFFICE CITY OF HIMAMAYLAN</p>	Prepared by: EDLIZ G. BANGUILA Architect III	Project Title: IMPROVEMENT OF ADMIN BUILDING	Recommending Approval:  ALMAR J. JAVA	Approved By:  GENESIS G. CAMARISTA, Ph.D.	Sheet Contents:	Sheet No. 
	Checked: REGIE CALVO Asst. City Engineer	Location: Brgy. Caradio-an, Himamaylan City	HEAD, PLANNING AND DEVELOPMENT	CAMPUS ADMINISTRATOR		




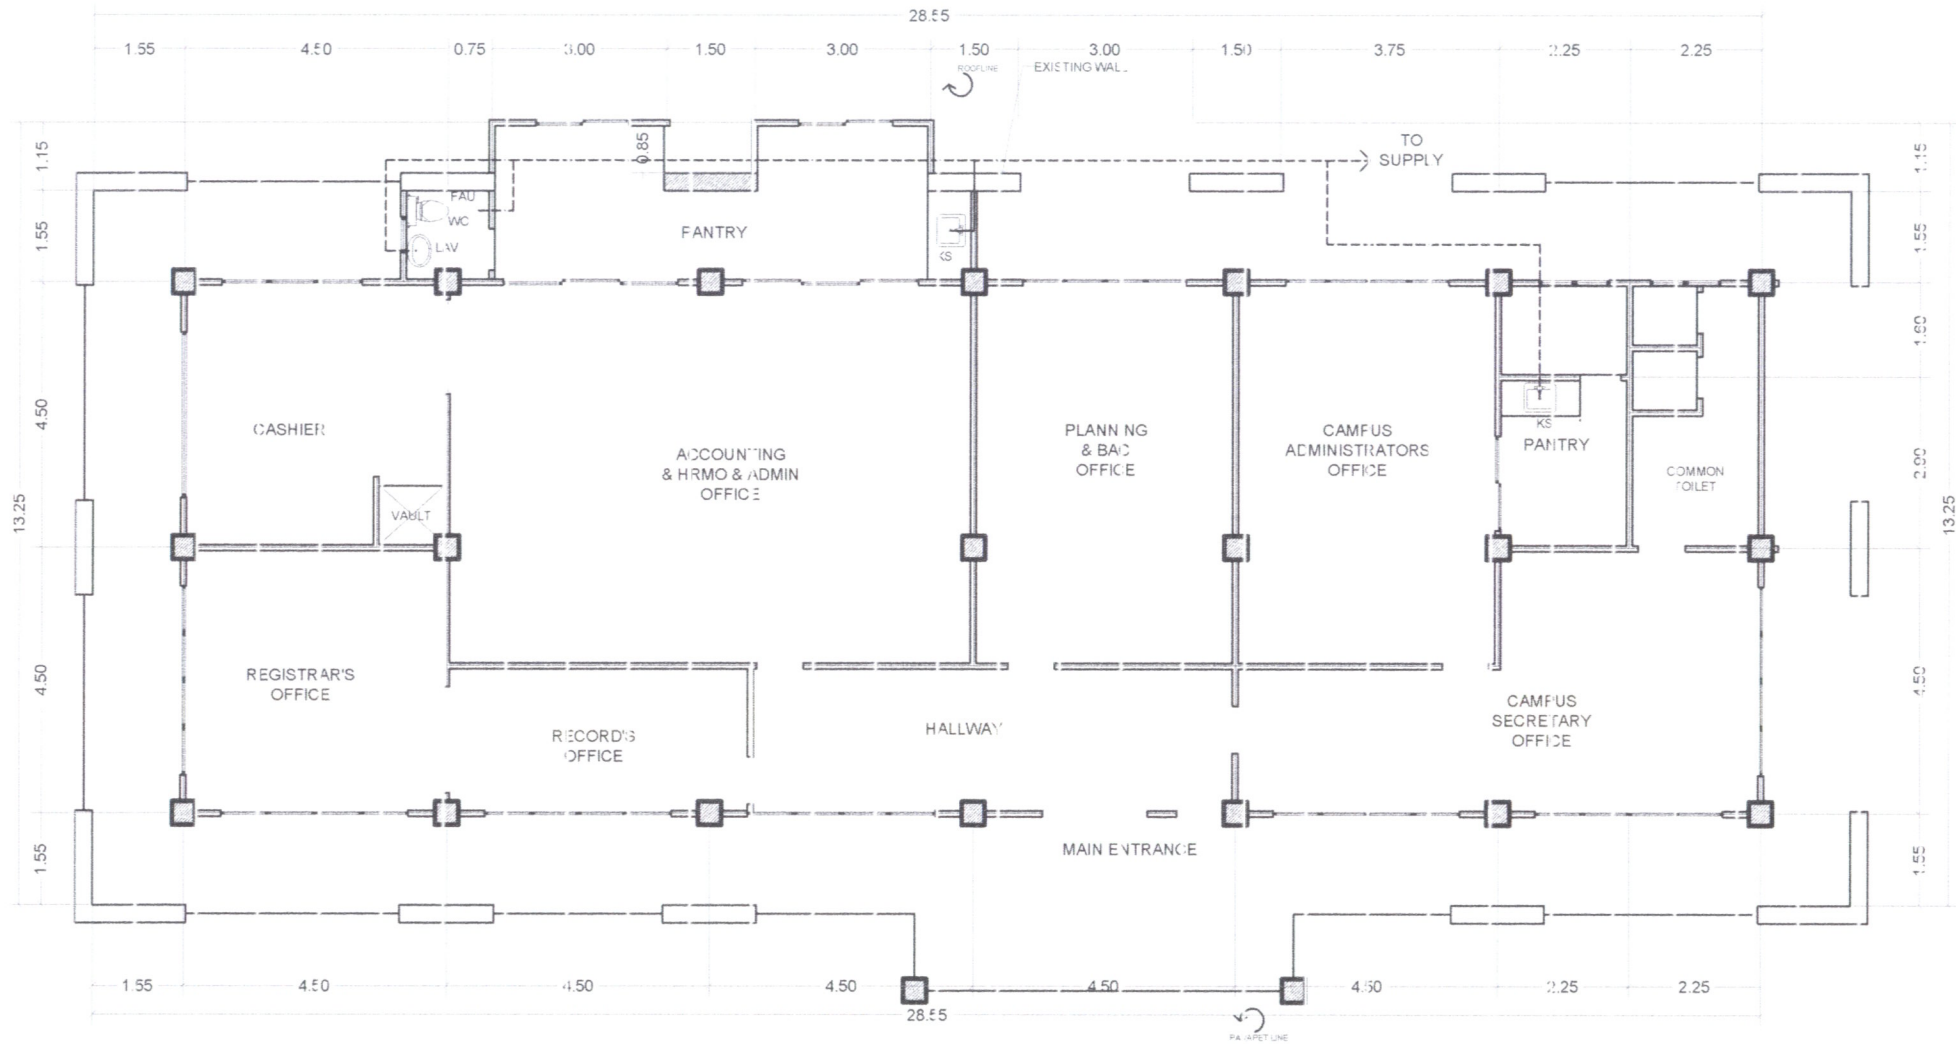


WATER SUPPLY LAYOUT
 SCALE: 1:120MTS



CITY ENGINEERS OFFICE
CITY OF HIMAMAYLAN

Prepared by: EDELIZ G. BANQUILAY <small>Architect III</small> REIGNHEL JOB BEDAURE <small>Architect I</small> Checked: REGIE J. CALVO <small>Asst. City Engineer</small>	Project Title: <p style="text-align: center;">IMPROVEMENT OF ADMIN BUILDING</p> Location: Bigy. Caridion-an, Himamaylan City	Recommending Approval: ALMAR J. JAVA HEAD, PLANNING AND DEVELOPMENT	Approved By: GENESIS G. CAMARISTA, Ph.D. CAMPUS ADMINISTRATOR	Sheet Contents:	Sheet No. <div style="text-align: center; border: 1px solid black; border-radius: 50%; width: 40px; height: 40px; margin: 0 auto; display: flex; align-items: center; justify-content: center;"> <div style="text-align: center;"> P-1 14 </div> </div>
---	--	---	---	-----------------	---

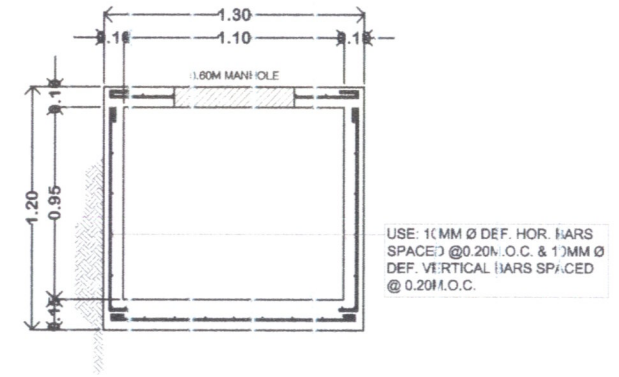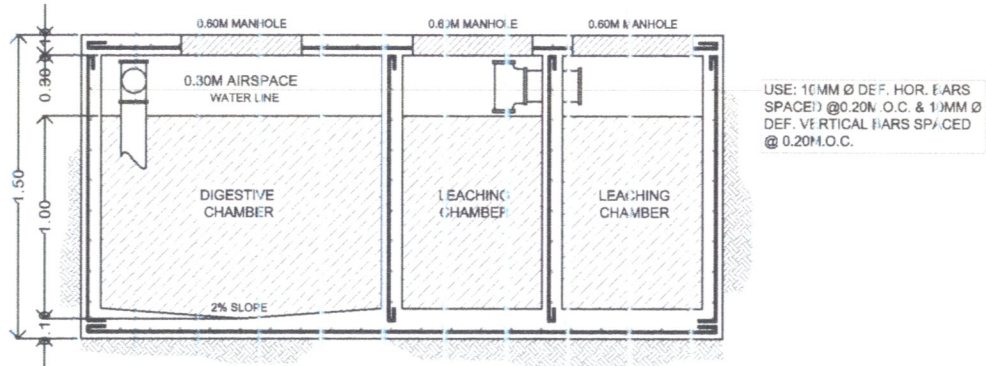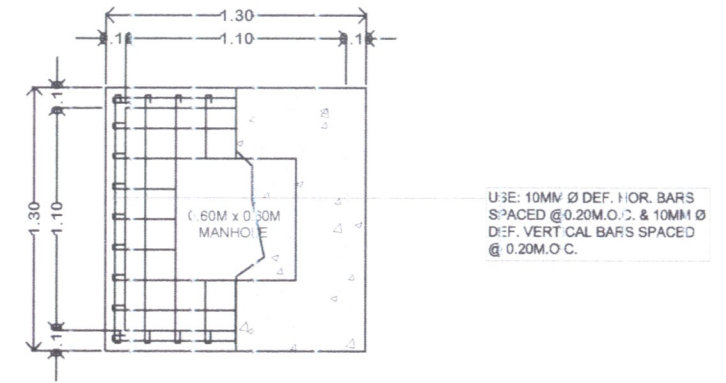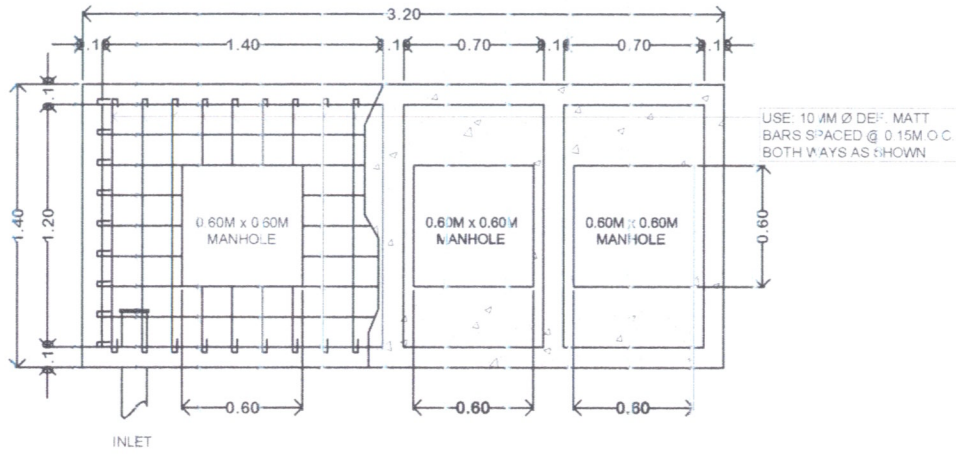

○ SEPTIC VAULT DETAIL
SCALE: 1:35MTS

○ CATCH BASIN DETAIL
SCALE: 1:35MTS



CITY ENGINEERS OFFICE
CITY OF HIMAMAYLAN

Prepared by:
EDELIZ G. BANQUILA
Architect III
REIGNHEL JOB BEDAURE
Architect I
Checked:
REGIE CALVO
Asst. City Engineer


Project Title:
**IMPROVEMENT OF
ADMIN BUILDING**
Location: Bigy, Cardiodan, Himamaylan City

Recommending Approval:
[Signature]
ALMARI J. JAVA
HEAD, PLANNING AND DEVELOPMENT


Approved By:
[Signature]
GENESIS G. CAMARISTA, Ph.D.
CAMPUS ADMINISTRATOR

Sheet Contents:

Sheet No.
P-1
15

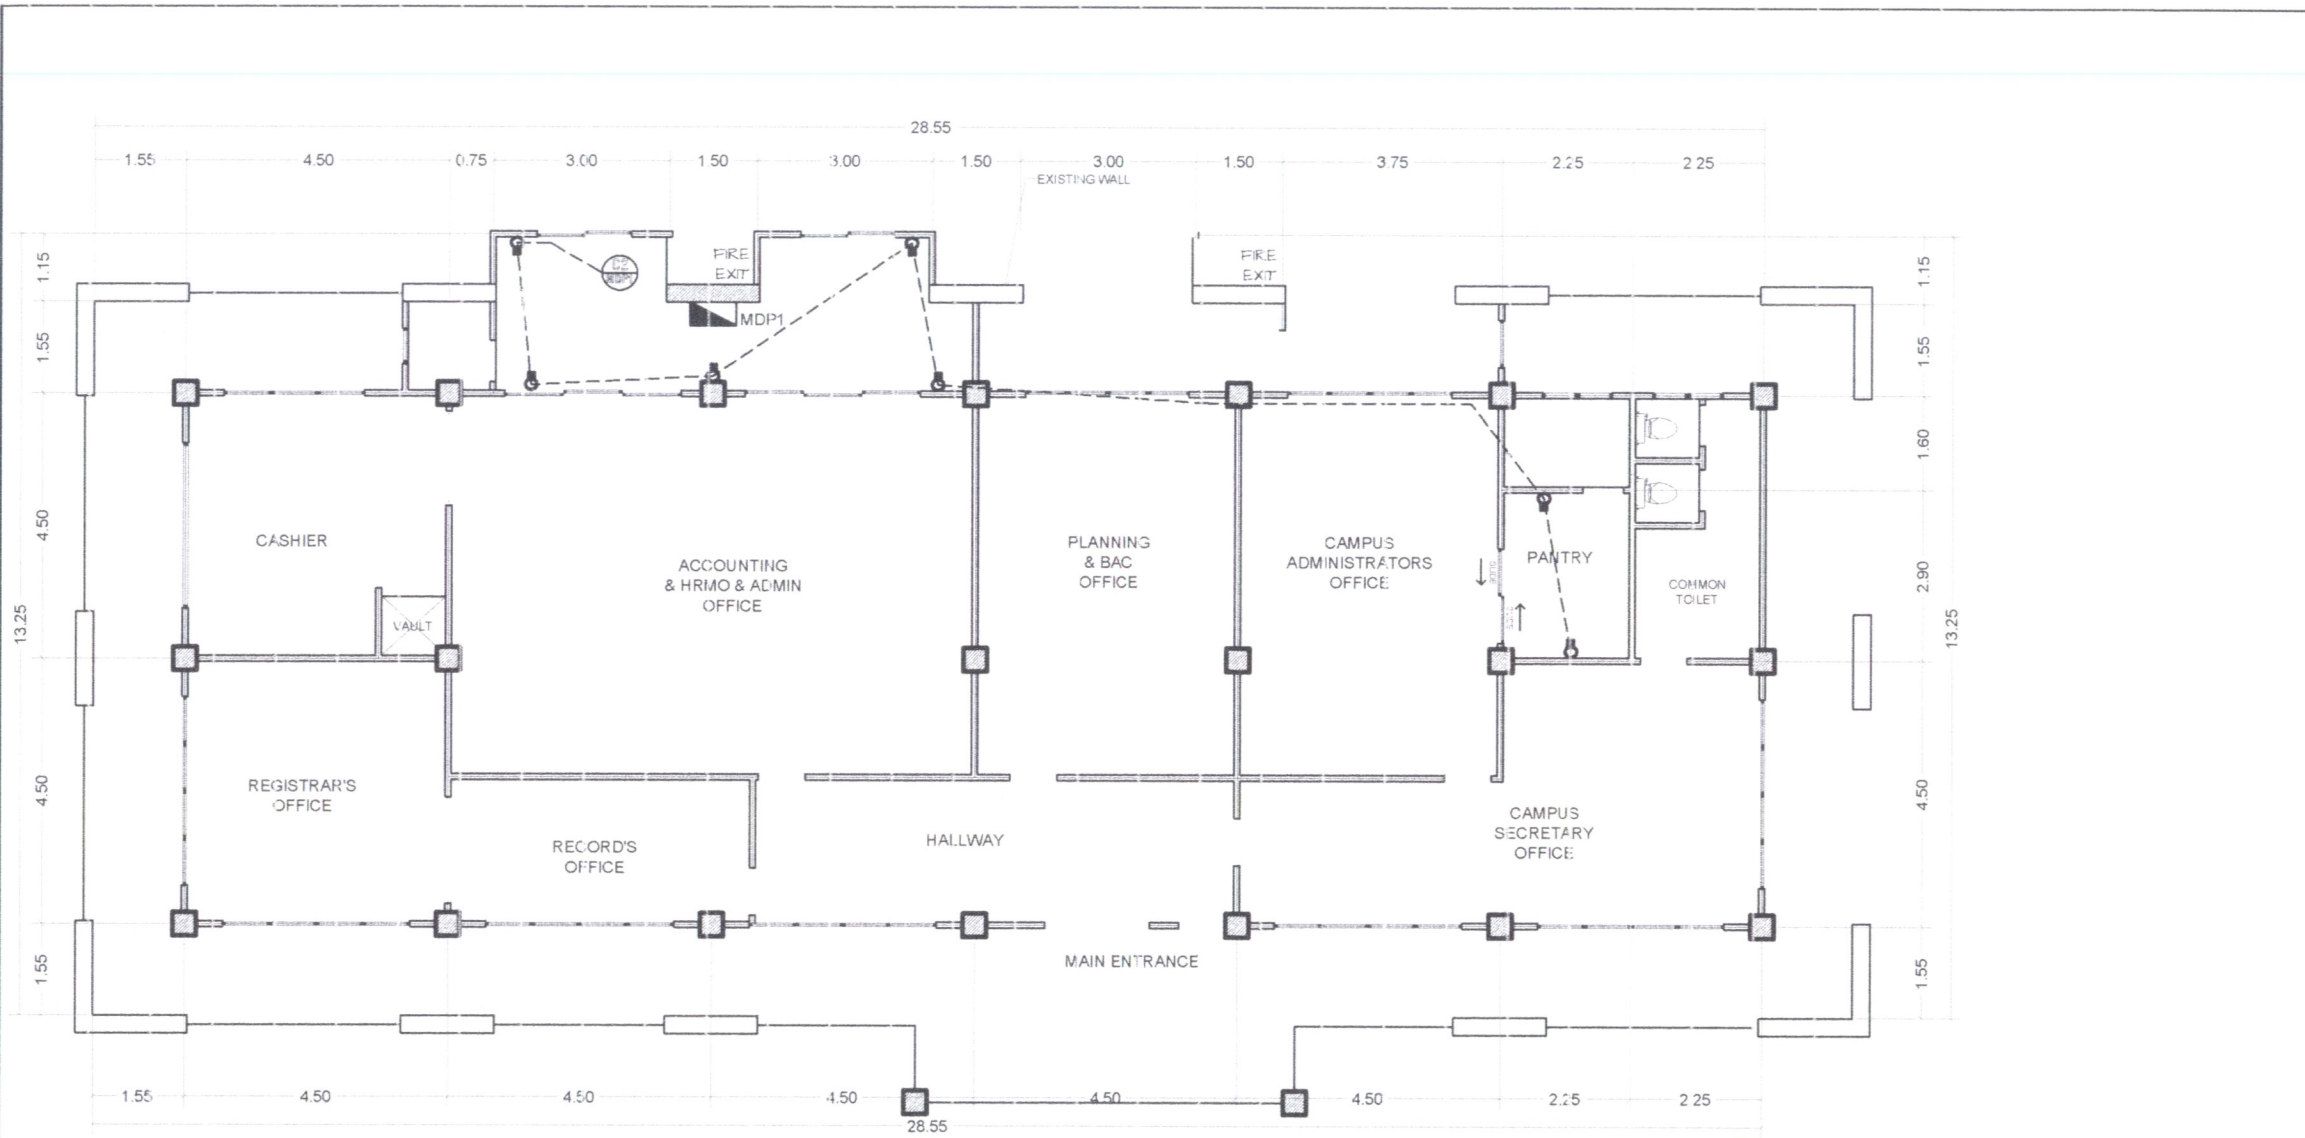

POWER LAYOUT

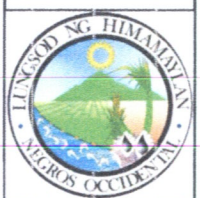

CITY ENGINEERS OFFICE
CITY OF HIMAMAYLAN

Prepared by:
JOEMARVE ONGSUCC
Engineer II

Checked:
REGIE T. CALVO
Asst. City Engineer

Project Title:
**IMPROVEMENT OF
ADMIN BUILDING**

Location: Brgy. Careadio-an, Himamaylan City

Recommending Approval:
Almar J. Java
ALMAR J. JAVA
HEAD, PLANNING AND DEVELOPMENT

Approved By:
Genesis G. Camarista
GENESIS G. CAMARISTA, Ph.D.
CAMPUS ADMINISTRATOR

Sheet Contents:

Sheet No.
E-2
17


COMPUTATION OF LOADS

MDP 1

CKT. NO	LOAD DESCRIPTION	POWER VOLT/AMP	VOLTAGE	CURRENT AMP	PROTECTION	SIZE OF WIRE	CONDUIT
CKT. 1 LO	10 - CEILING LIGHT OUTLET	1000 W	230 V	7.39 A	16 AT	2.0mm sq (#14) THW	3/4" Φ PVC PIPE
CKT. 2 LO	7 - CONVENIENCE OUTLET	2520 W	230 V	14.08 A	20 AT	3.5mm sq (#12) THW	3/4" Φ PVC PIPE

TOTAL CONNECTED LOAD = 3520 W 10.95A

Total Power = 4940 VA
 $I_c = [4940/230] 150\%OL \times 0.8 = 13.40 \text{ Amp}$ $I_p = [4940/230] 175\%OL \times 0.8df = 15.33 \text{ Amp}$
 Use # 6 THW stranded cu.wire Use: 100 AT, 230V,60Hz,1phase MCB

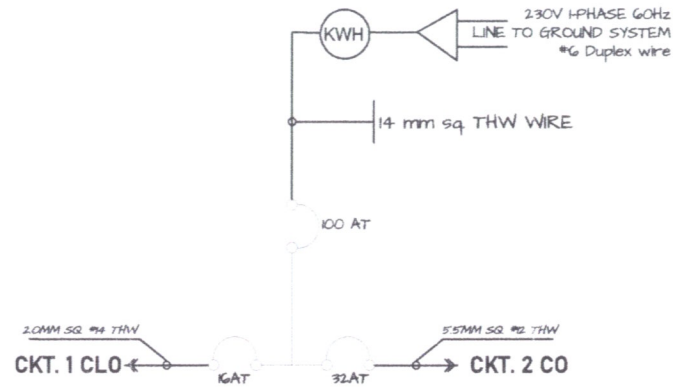

○ SCHEDULE OF LOADS

○ SINGLE LINE DIAGRAM

LEGEND	
	CIRCUIT BREAKER
	MAIN DISTRIBUTION PANEL
	CIRCUIT LINE
	SWTCH LINE
	LED BULB DOWLIGHT
	3- GANG CONVENIENCE OUTLET
	2- GANG CONVENIENCE OUTLET
	AIR-CONDITIONING UNIT OUTLET
	ONE-GANG SWITCH
	ONE-GANG SWITCH

	CITY ENGINEERS OFFICE CITY OF HIMAMAYLAN	Prepared by:	Project Title:	Recommending Approval:	Approved By:	Sheet Contents:	Sheet No.
		JOEMARIE ONGSUOCO <small>Engineer II</small>	IMPROVEMENT OF ADMIN BUILDING	 ALMAR J. JAVA	 GENESIS G. CAMARISTA, Ph.D.		
	Checked: REGIE I. CALVO <small>Asst. City Engineer</small>	Location: Brgy. Caradio-an, Himamaylan City	HEAD, PLANNING AND DEVELOPMENT	CAMPUS ADMINISTRATOR			