



**1** GROUND FLOOR ELECTRICAL PLAN  
A-02 SCALE 1:150 M

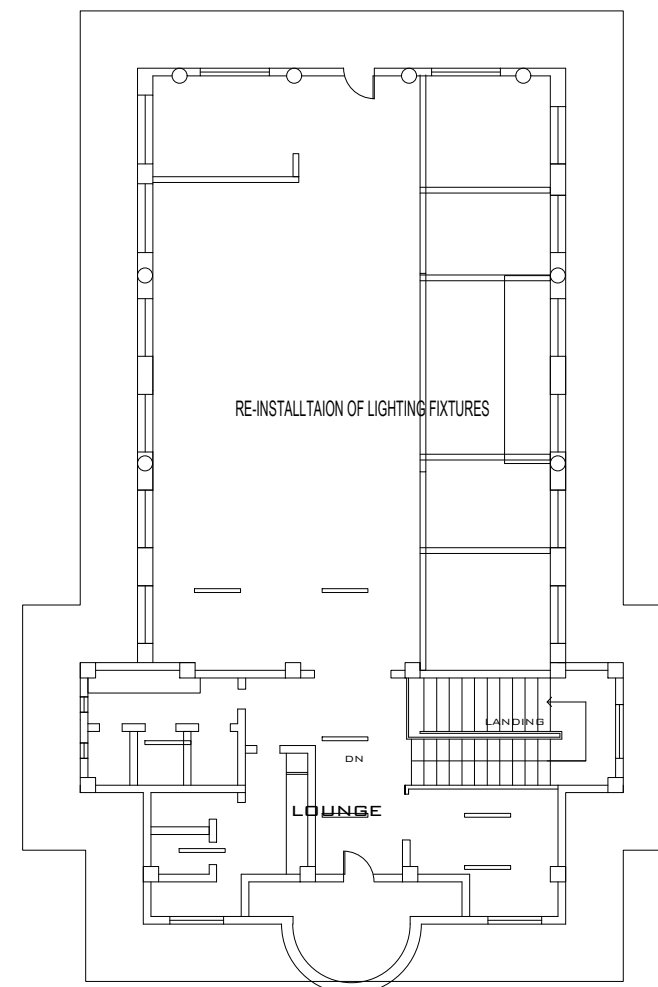

**1** SECOND FLOOR ELECTRICAL PLAN  
A-02 SCALE 1:150 M

— T8 LED LIGHTS (NEW AND RE-INSTALLATION)  
⊕ CONVENIENCE OUTLETS (NEW AND RE-INSTALLATION)

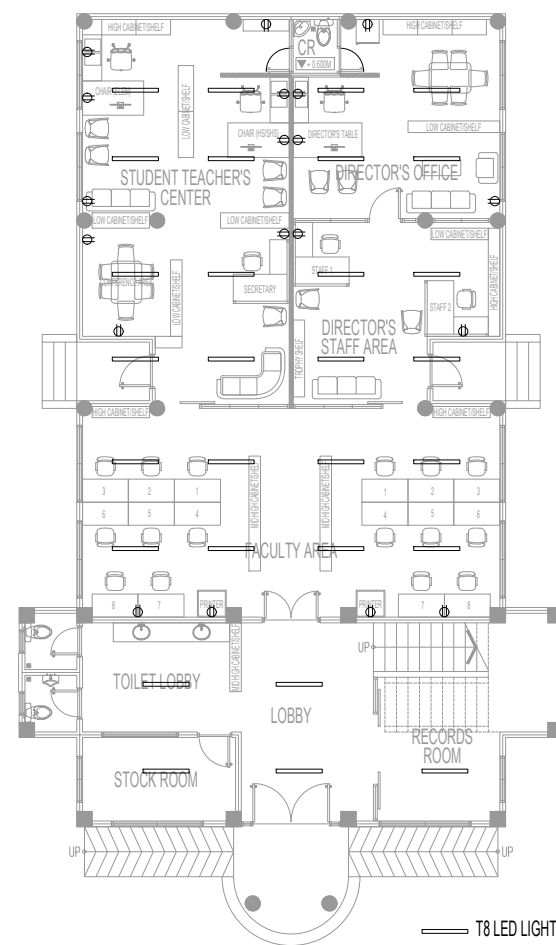

**West Visayas State University**  
(Formerly Iloilo Normal School)  
Luna St., La Paz, Iloilo City 5000  
Iloilo, Philippines  
\*Toll-free: (063) (033) 320-0870 to 78 \*\*Telex: No. (033) 320-0879  
\*Website: www.wvsu.edu.ph \*Email Address: [cpo@wvsu.edu.ph](mailto:cpo@wvsu.edu.ph)

R. A. 545 ART. 2 SEC. 25 (4)  
ALL DESIGNS, DRAWINGS, SPECIFICATIONS AND COPIES THEREOF,  
PREPARED AND FURNISHED BY THE ARCHITECT IN CONNECTION WITH THIS  
PROJECT, ARE INSTRUMENTS OF PROFESSIONAL SERVICE, AS  
INSTRUMENTS OF PROFESSIONAL SERVICE THEY ARE THE PROPERTY OF  
THE ARCHITECT WHETHER THE WORK FOR WHICH THEY ARE MADE MAY BE  
EXECUTED OR NOT, AND NOT TO BE REPRODUCED OR USED ON OTHER  
WORK EXCEPT BY WRITTEN AGREEMENT WITH THE ARCHITECT.

<b>CERTIFIED BY:</b>		<b>CHECKED BY:</b>		<b>PROJECT TITLE:</b>	
AR. GERARD L. IBAÑEZ, UAP		AR. GERARD L. IBAÑEZ, UAP		REHABILITATION OF TEACHERS CENTER (INTERIOR)	
PRC No. 18422	TIN: 931-269-265	OIC HEAD, CPPO		LOCATION : WEST VISAYAS STATE UNIVERSITY - MAIN CAMPUS, LA PAZ, ILOILO CITY	
PTR No. 8090356	D.I.: 01-06-23				

<b>RECOMMENDING APPROVAL:</b>	<b>APPROVED BY:</b>	<b>SHEET CONTENTS:</b>	<b>SHEET NUMBER</b>
WILHELM P. CERBO, Ed.D.	JOSELITO F. VILLARUZ, M.D., PhD., FPPS	AS SHOWN	2
DIRECTOR, UPDO	PRESIDENT, WVSU	DESIGNED BY:	CHECKED BY:
		ACAD BY:	DATE: